


REV.	ECN.	ND.	APPD.
A	BC-07-7079002	Sam	11/21/07

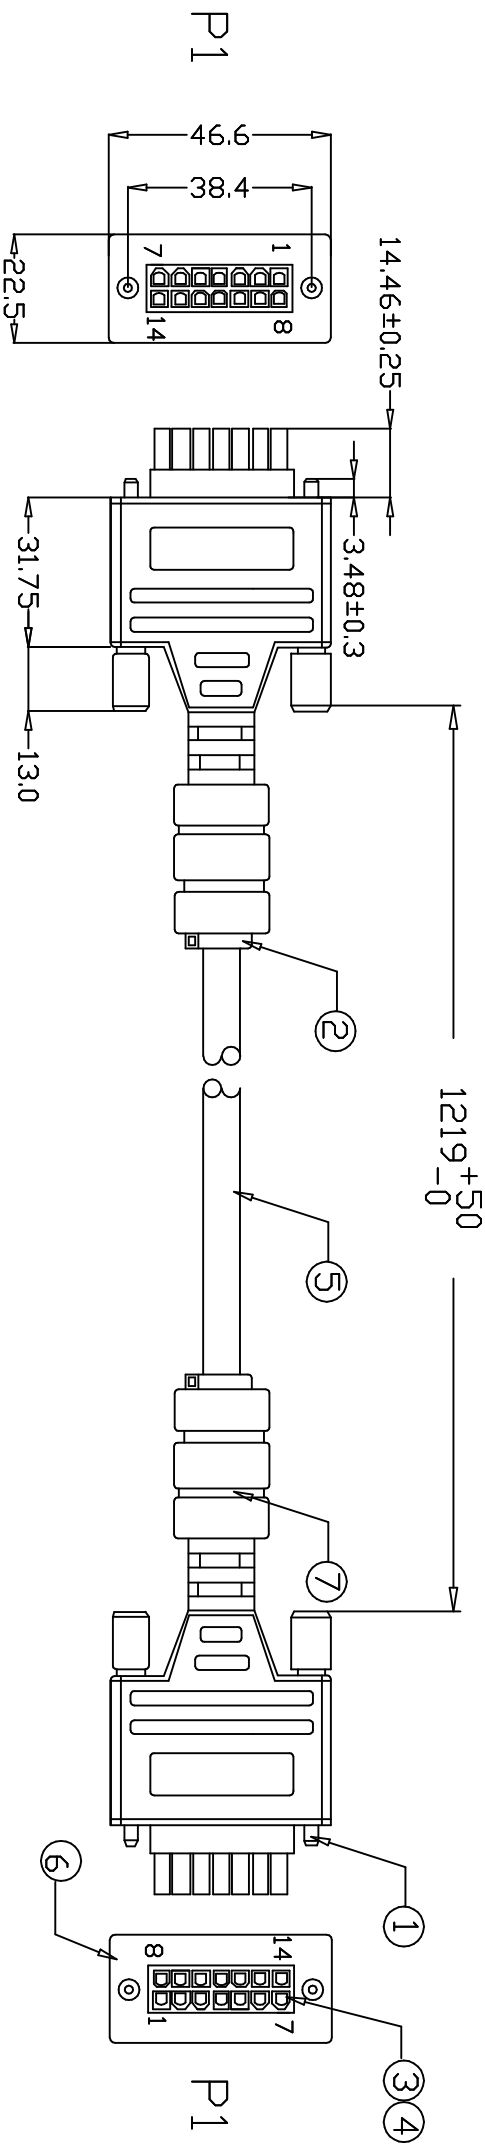

P1	COLOR	P2
1	YELLOW	1
2	YELLOW/BLACK	2
3	YELLOW/BROWN	3
4	YELLOW/RED	4
5	WHITE/BROWN	5
6	WHITE/PINK	6
7	WHITE/DRANGE	7
8	WHITE	8
9	WHITE/GRAY	9
10	WHE/YELLOW	10
11	WHITE/BLACK	11
12	WHITE/PURPLE	12
13	WHITE/BLUE	13
14	WHITE/GREEN	14

NOTES:
 Δ DIMENSION SHALL BE INTERPRETED PER ANSI Y14.5M-1982
 2. HARMFUL MATERIAL CONTROL PLEASE FOLLOW DDC. NO. 'EPI12'

NO	DESCRIPTION	UNIT	Q'TY	FOXCDDN P/N	REMARK
1	JACK SCREW	PC	4	060-0001-555	FOXCDDN060-0001-555
2	CABLE TIE	PC	2	080-0015-754	FOXCDDN080-0015-754
3	CONTACT	PC	28	050-0122-669	MOLEX:39-00-0153
4	HOUSING	PC	2	002-0114-193	MOLEX:39-01-2145
5	WIRE(GRAY)	F+	A/R	014-0001-211	UL2936,14C,18AWG
6	DIE-CAST	PC	4	027-0001-026	FOXCDDN027-001-026
7	FERRITE	PC	2	020-4001-314	FOXCDDN16mm*28mm*10mm

X.±	X'.±	UNITS	mm	NAME(INTENDED USE)
.X±	.X'±	MAT'L		
.XX±	.XX'±	FINISH		
.XXX±	.XXX'±			

THESE DRAWINGS AND SPECIFICATIONS ARE THE PROPERTY OF HON HAI PRECISION IND. CO. ANY REPRODUCTION OR USE IN ANY MANNER WITHOUT THE PRIOR WRITTEN CONSENT OF HON HAI PRECISION IND. CO., LTD.	DR: Life Liao 10/20/04	DWG NO: 356-0000-4299	SCALE SHEET 1/1
--	------------------------	-----------------------	-----------------

REV.	ECN.	ND.	APPD.
A	BC-07-7079002	Sam	11/21/07

P1	COLOR	P2
1	YELLOW	1
2	YELLOW/BLACK	2
3	YELLOW/BROWN	3
4	YELLOW/RED	4
5	WHITE/BROWN	5
6	WHITE/PINK	6
7	WHITE/DRANGE	7
8	WHITE	8
9	WHITE/GRAY	9
10	WHE/YELLOW	10
11	WHITE/BLACK	11
12	WHITE/PURPLE	12
13	WHITE/BLUE	13
14	WHITE/GREEN	14

NOTES:
 Δ DIMENSION SHALL BE INTERPRETED PER ANSI Y14.5M-1982
 2. HARMFUL MATERIAL CONTROL PLEASE FOLLOW DDC. NO. 'EPI12'